







FOR BIDDING

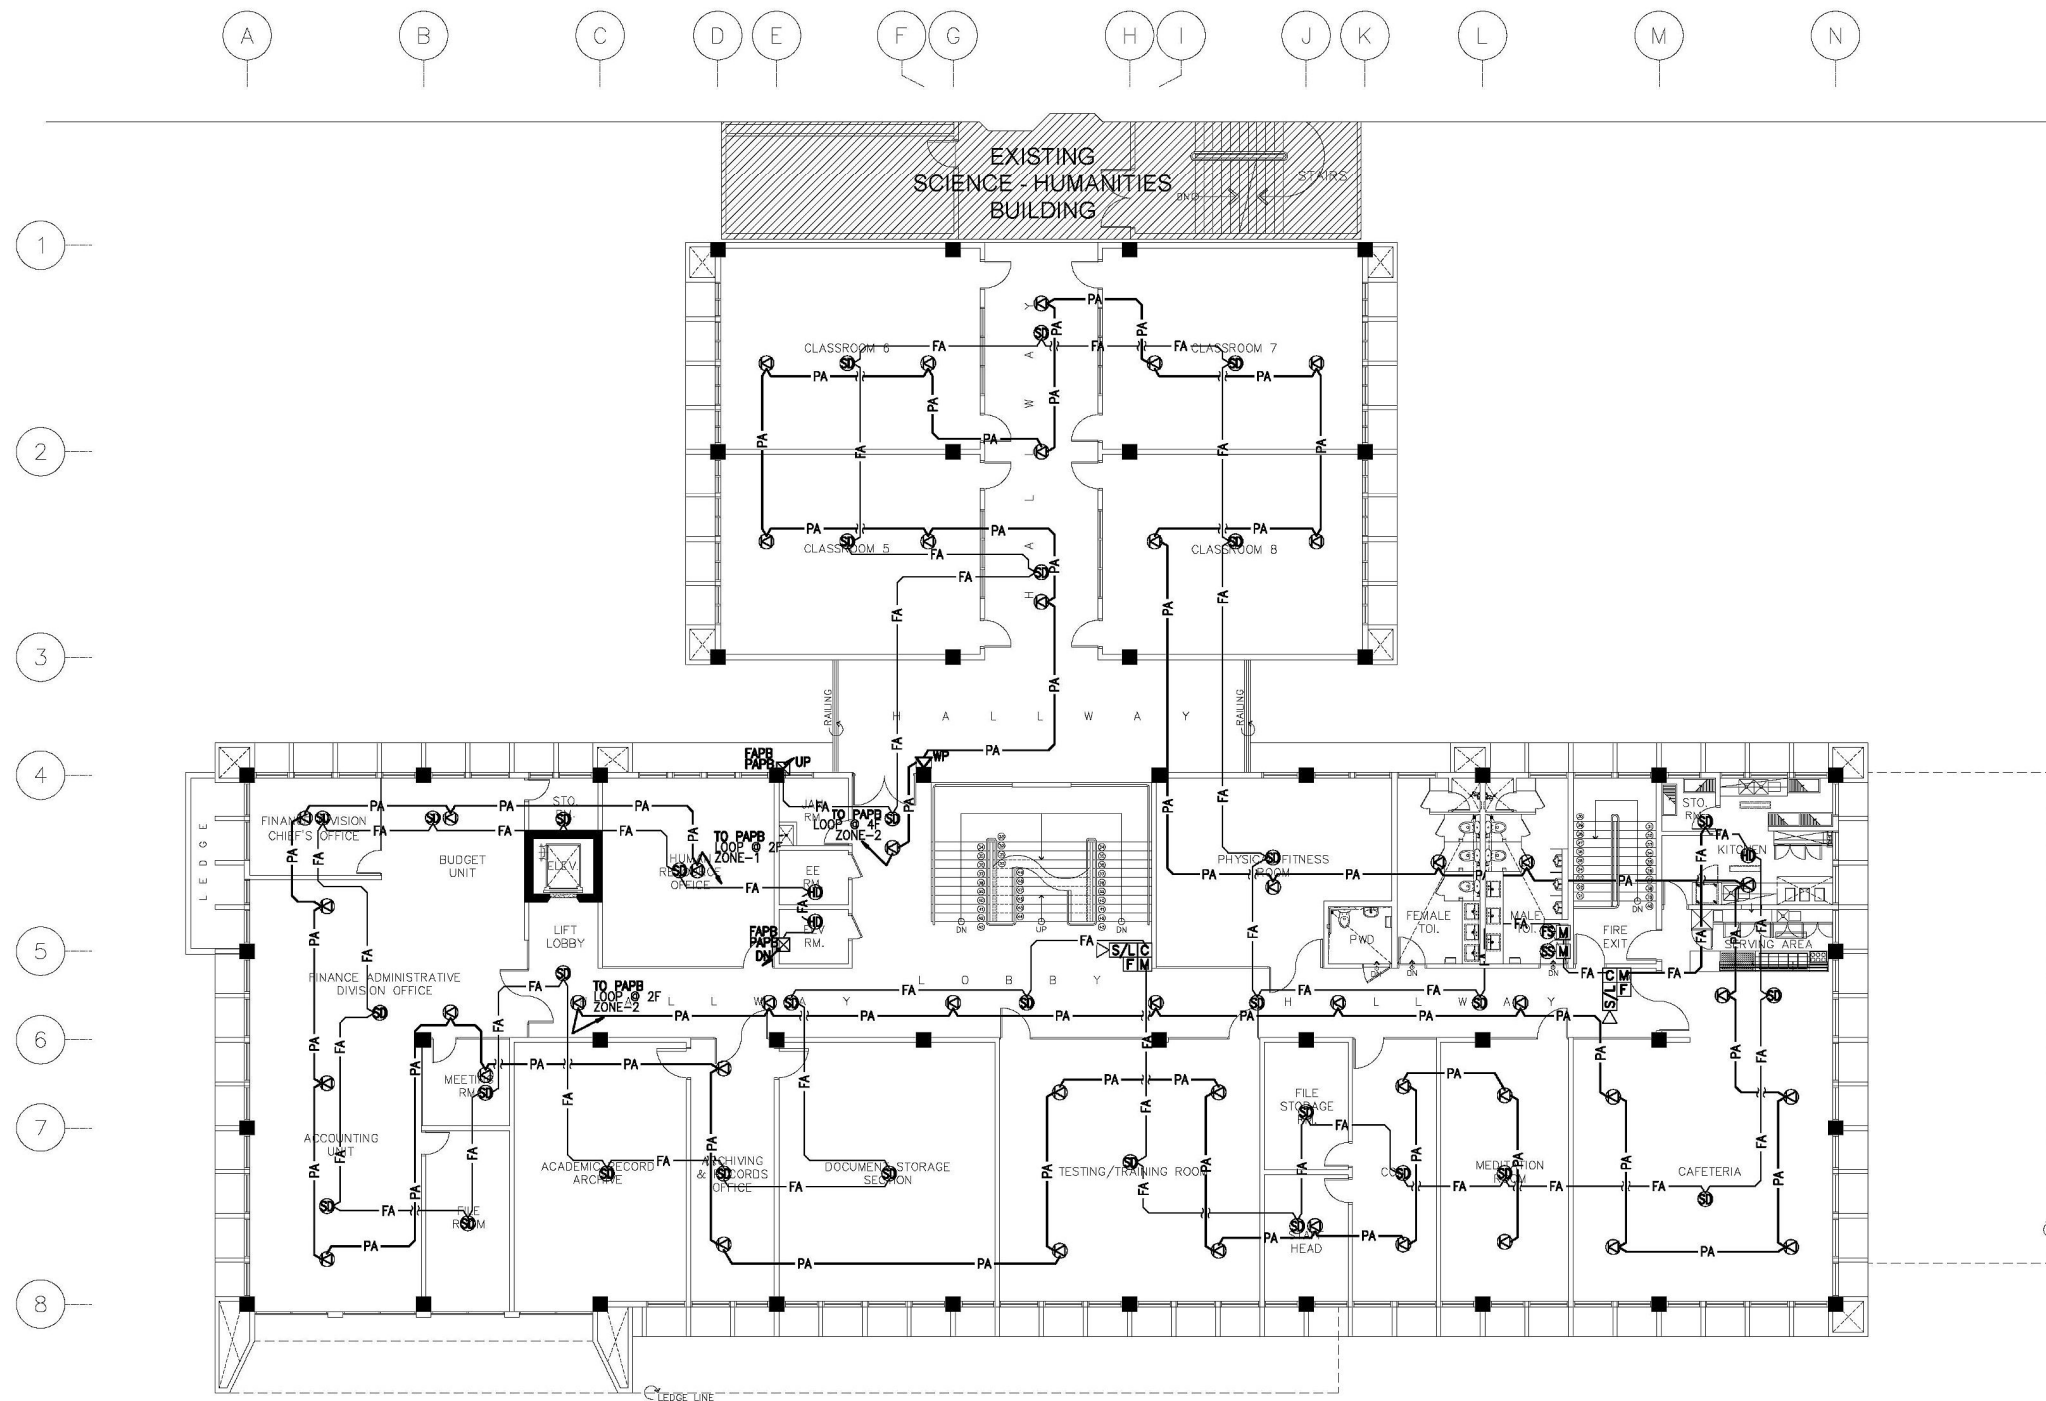

LEGENDS	DESCRIPTION
SD	SMOKE DETECTOR
HD	HEAT DETECTOR
FS	FLOW SWITCH
SS	SUPERVISORY SWITCH
F	MANUAL PULL STATION
C	CONTROL MODULE
M	MONITOR MODULE
S/L	FIRE ALARM SOUNDER WITH STROBE LIGHT
K	CEILING MOUNTED SPEAKER, 6W
W	WALL MOUNTED SPEAKER, 10W
PB	PULLBOX
UD	RISER UP/DOWN
UP	RISER UP
DN	RISER DOWN
FA	FIRE ALARM SYSTEM LAYOUT (25mm ϕ IMC)
PA	PUBLIC ADDRESS SYSTEM LAYOUT (25mm ϕ IMC)
WP	WITH WEATHERPROOF ENCLOSURE
FAPB	FIRE ALARM SYSTEM PULLBOX
PAPB	PUBLIC ADDRESS SYSTEM PULLBOX

A THIRD FLOOR FIRE DETECTION & ALARM SYSTEM AND PUBLIC ADDRESS SYSTEM LAYOUT
EC3-01c SCALE 1 : 125M

CONSULTANT:	PRINCIPAL ARCHITECT:	PROF. ELECTRONICS ENGINEER:	PROJECT TITLE:	OWNER:	APPROVED BY:	SHEET CONTENTS:	REVISION:	PROJECT NO.:	SHEET NO.:
 ARCE•BAILON•ARCE ARCHITECTS•ENGINEERS•CONSULTANTS 14 SCOUT BORROMEIO STREET, SOUTH TRIANGLE, QUEZON CITY. TRUNKLINE: 3552020 FAX NO.: 3551080 WWW.ARCEBAILONARCE.COM	 MARIANO S. ARCE, JR. fuop	 RAYMOND C. MEDINA AC/PLATE/ASEAN ENGINEER	CONSTRUCTION OF THE ADMINISTRATIVE BUILDING AND REHABILITATION/EXPANSION OF ACADEMIC AND DORMITORY BUILDING	 PHILIPPINE SCIENCE HIGH SCHOOL MAIN CAMPUS	 VIRGINIA P. ANDRES SGO DIRECTOR II	THIRD FLOOR FIRE DETECTION & ALARM SYSTEM AND PUBLIC ADDRESS SYSTEM LAYOUT		17-05 17-07	EC3-01c
REG. NO. 6844 PTR. NO. 3865672 TIN 129-343-671 DATE: 09/17/17 QC	REG. NO. 0072 PTR. NO. 2553039 TIN 197-774-192 DATE: JAN. 09, 2017	LOCATION: Agham Road, Diliman, Quezon City				DESIGNED BY: RC/MCC	CAD: me	CHECKED BY: DMV/CLC/NR	DATE: OCTOBER 2017

REPUBLIC ACT 9266: This drawing, as an instrument of service, is the property of ARCE-BAILON-ARCE ARCHITECTS, registered Architects and as such must not be reproduced or copied in part or in whole without their permission. All drawings are to be returned when no longer in use. PRESIDENTIAL DECREE NO. 49: "Protection of Intellectual Property" Works of Art, Architecture, Model and Designs are creative works and considered as part of the Intellectual property of the author.